


TILE	DESCRIPTION
	AIR SAMPLING INTAKE GRILLE c/w TEMPERATURE/HUMIDITY SENSOR (FREE ISSUE)
	3 x 240V/13A ELECTRICAL SOCKETS
	2 x 20" NON-DICOM PACS VIEWER c/w COMPUTER
	LEXAN FOIL HOSEPROOF KEYBOARD
	ANALOGUE TIME OF DAY CLOCK
	DIGITAL ELAPSED TIME CLOCK
	ELAPSED TIME CLOCK START/STOP/RESET
	10" HMI TOUCHSCREEN c/w THE FOLLOWING
	i) DIGITAL TEMPERATURE/HUMIDITY INDICATORS
	ii) TEMPERATURE/HUMIDITY CONTROLLERS
	iii) 2 No. GENERAL LIGHTING CONTROLS AND DIGITAL DIMMING
	iv) MAIN OPERATING LIGHT ON/OFF
	v) SATELLITE OPERATING LIGHT ON/OFF
	vi) FULL MEDICAL GAS FAULT ALARM
	vii) FULL IPS/UPS FAULT ALARM
	viii) VENTILATION PLANT CONTROLS/ALARMS/INDICATORS
	ix) GENERAL POWER INDICATORS
	x) AGSS CONTROL SWITCHES/INDICATORS
	xi) DOOR INTERLOCK
	xii) "THEATRE IN USE" ON/OFF SWITCHES
	xiii) ULTRA CLEAN VENTILATION (UCV) CONTROLS/INDICATORS

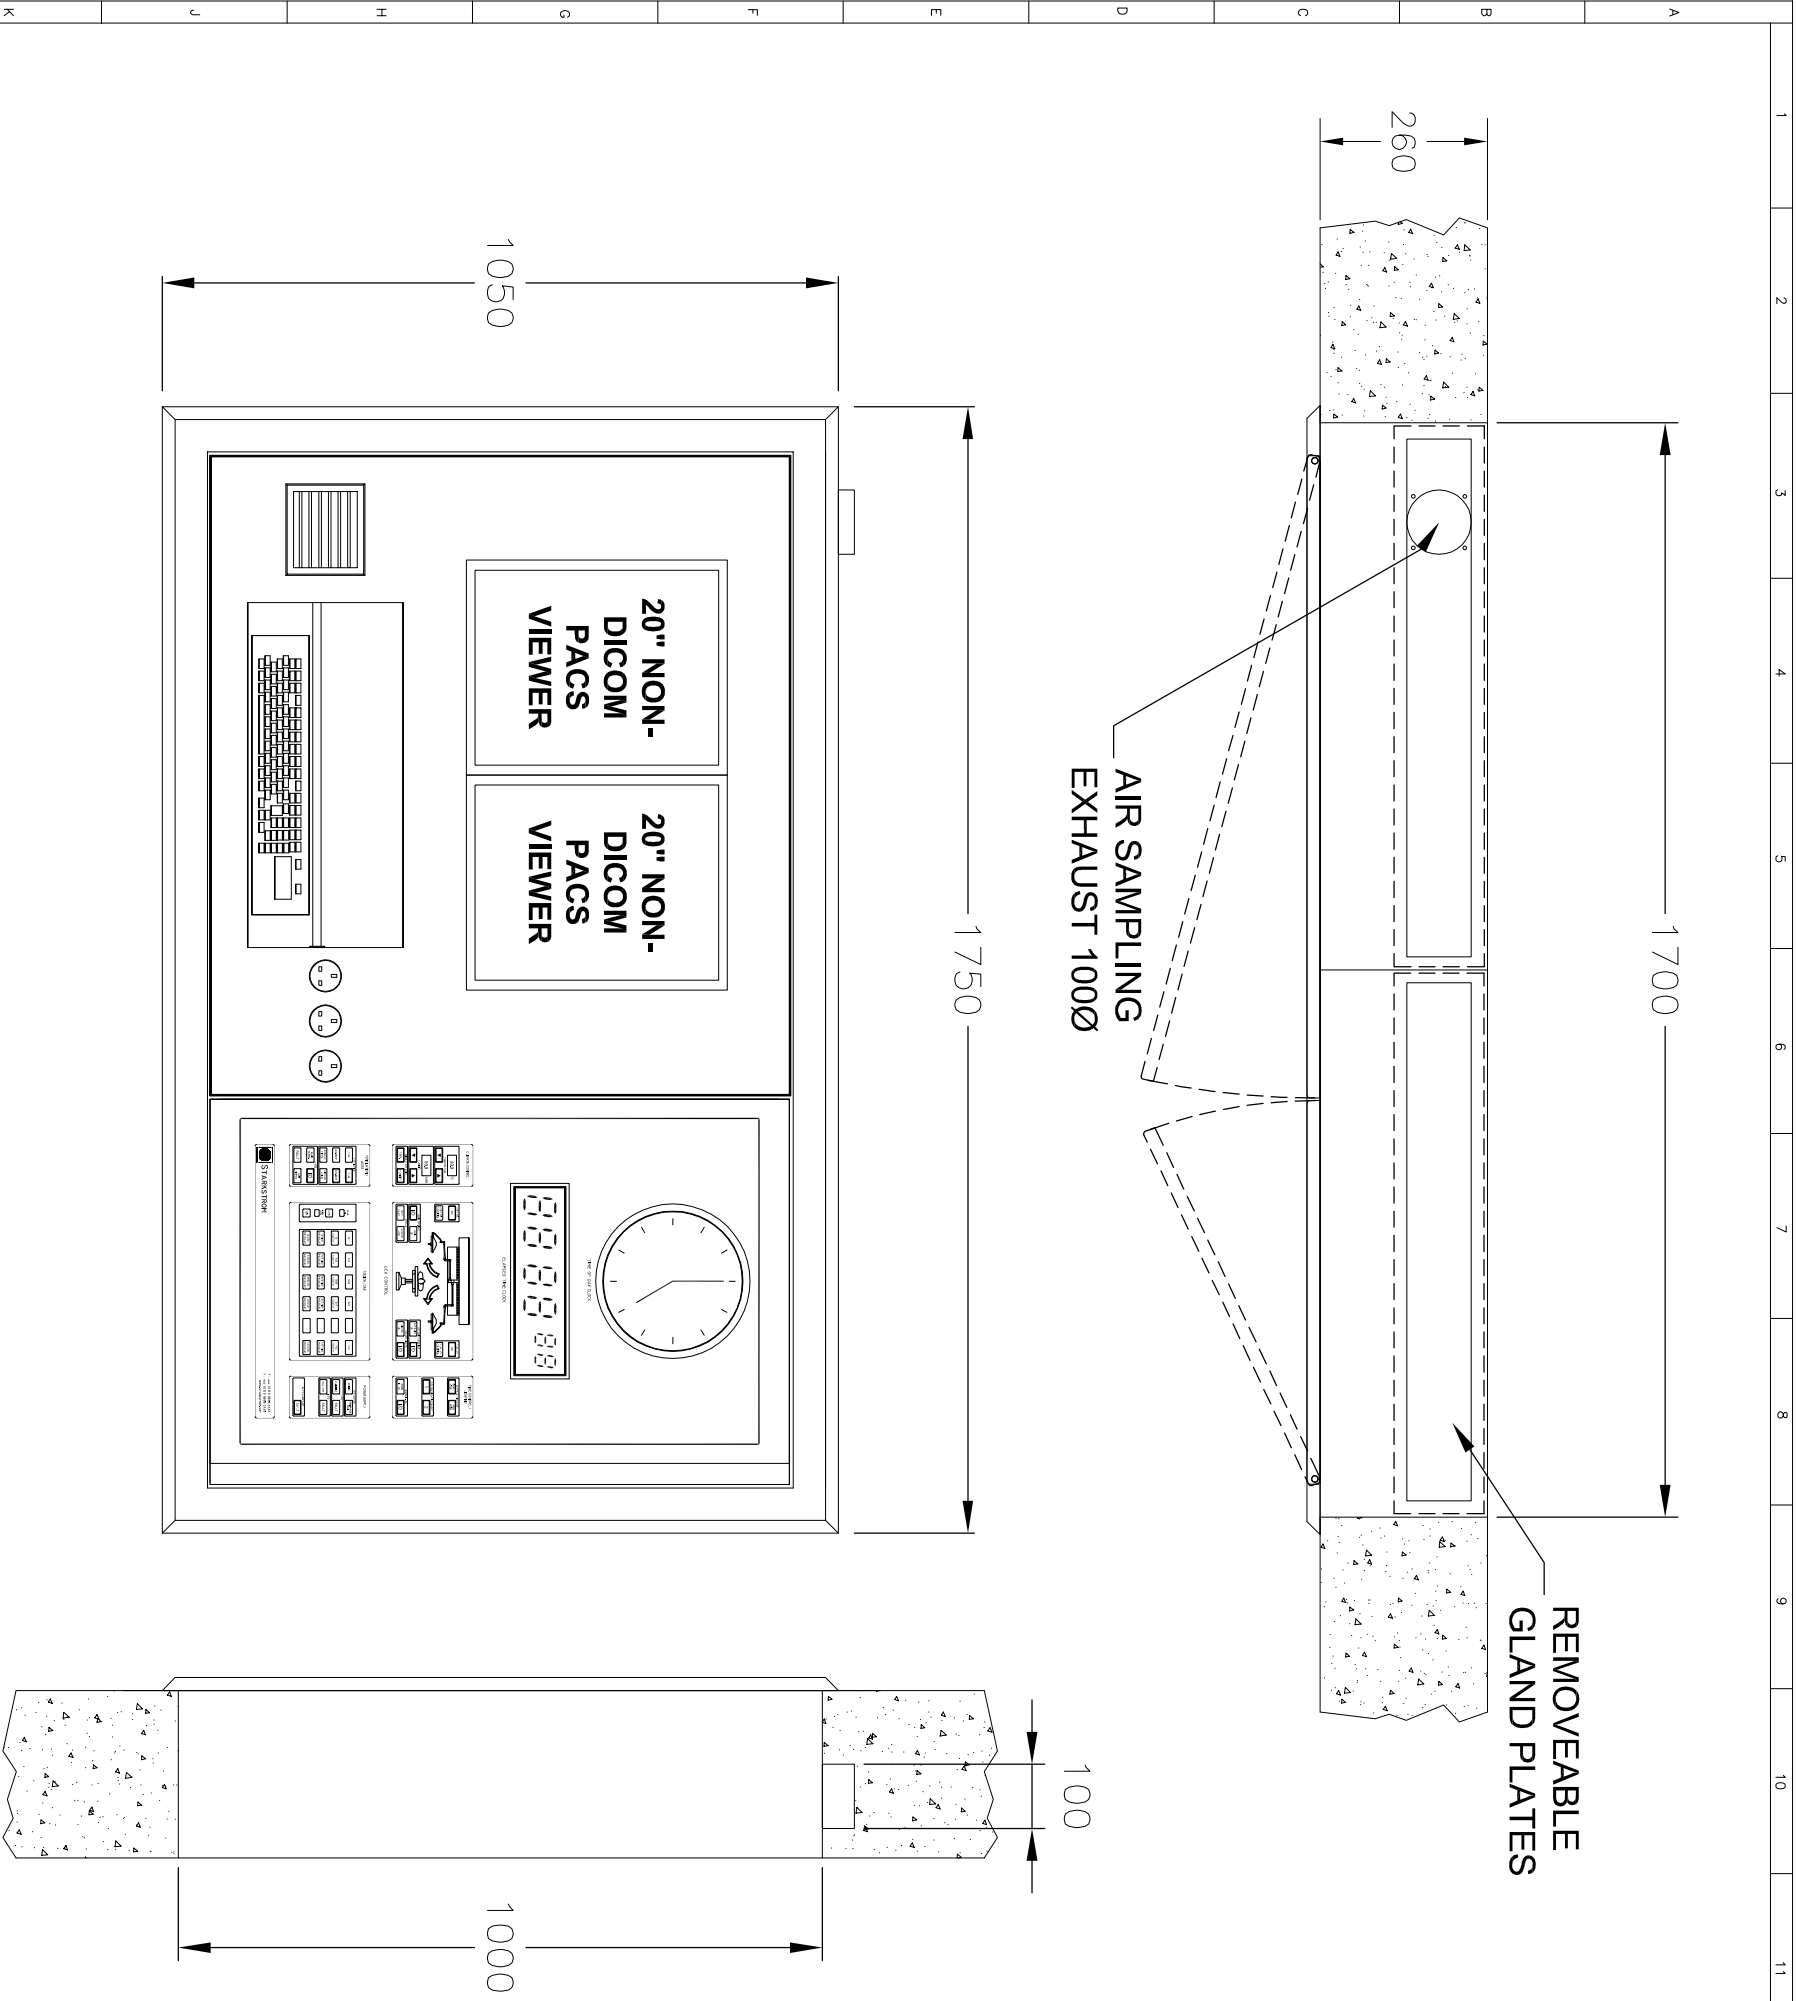

CONSTRUCTION
 FRONT FASCIA, DOOR & TILES OF 14swg GRADE 304 STAINLESS STEEL EPOXY POWDER COATED WHITE.
 1ST FIX BACK BOX OF 16swg ZINTEC MILD STEEL, EPOXY POWDER COATED WHITE.

Starkstrom Ltd

256 FIELD END ROAD
 EASTCOTE, RUISLIP
 MIDDLESEX, HA4 9UW
 Telephone : +44 (0)208 8683732 Fax : +44 (0)208 8683736
 Website : www.starkstrom.com e-mail : sales@starkstrom.com

THIS DRAWING IS THE EXCLUSIVE PROPERTY OF BRG MEDICAL DESIGN LTD. AND MUST NOT BE COPIED OR REPRODUCED IN ANY WAY WITHOUT EXPRESS CONSENT IN WRITING. THE DRAWING IS TO BE RETURNED TO BRG MEDICAL DESIGN LTD. ON COMPLETION OF WORK. IT IS TO BE TREATED AS STRICTLY CONFIDENTIAL AND MUST NOT BE DISCLOSED TO ANY THIRD PARTY WITHOUT EXPRESS CONSENT IN WRITING. COPYRIGHT BRG MEDICAL DESIGN LIMITED@2010

GENERAL NOTES: DRAWING TO BE REVISIONS TO BE SHOWN IN ALL DIMENSIONS IN MILLIMETERS UNLESS OTHERWISE STATED. REMOVE ALL DIMS AND SHAWP EDGES.

MATERIAL: _____
 SPECIFICATION: _____
 FINISH: _____
 SURFACE TEXTURE: _____

DO NOT SCALE

THIRD ANGLE PROJECTION

UNLESS OTHERWISE STATED

DATE	MODIFICATION	SIG.	ISSUE	DATE	MODIFICATION
17.02.10	UPDATED WTOP TO INCLUDE MORE CONTROLS	SM	D		
17.02.10	REPLACED aTCP WITH WTOP	SM	C		
10.02.10	PANEL DID INCLUDE TWIN X-RAY + 1 PACS	SJP	B		
01.12.09	FIRST ISSUE	SJP	A		

SURGEONS' THEATRE CONTROL PANEL REF. 3W-FA-FM-11T-S

DRG No: T-372-01

CONTRACT: GARTNAVAL HOSPITAL

ISSUED FOR: INFORMATION ONLY

SCALE: NTS
 DRAWN: SJP
 APPROVED: _____

DATE: 10.02.10
 CONTINUED ON SHEET: 04531

JOB NUMBER: _____